

General Notes


1. This drawing is © copyright Hampshire County Council 2017. No unauthorised reproduction of any kind is permitted.
2. No dimensions to be scaled from this drawing. Verify all dimensions prior to construction. Immediately report any discrepancies on the document to the Architect/Contract Administrator. This document shall be read in conjunction with associated models, specifications and related consultant's documents.
3. Drawing to be read with all relevant Structural, M&E, Public Health, Landscape, Civils and Interiors drawings and specifications.
4. This map is reproduced from Ordnance Survey material with the permission of Ordnance Survey on behalf of the controller of Her Majesty's Stationery Office © Crown copyright. Unauthorised reproduction infringes Crown Copyright & may lead to legal action against you and your employer. Ordnance Survey

Notes:

Legend

- RWO Rainwater Outlet/Overflow
- RL Roof Light
- RWP Rainwater Pipe
- Direction of Water Flow (Min 1:80 falls)
- PV Photovoltaic Panels
- High Performance Mineral Felt Roof Finish
- Flat Roof Gutter
- Aluminium Coping

NOTE: PV Array is shown indicatively. The quantity will be determined by the requirement to meet Part L of the Building Regulations. The PV will be subject to specialist design, and the number of panels/ area of panels is subject to change.

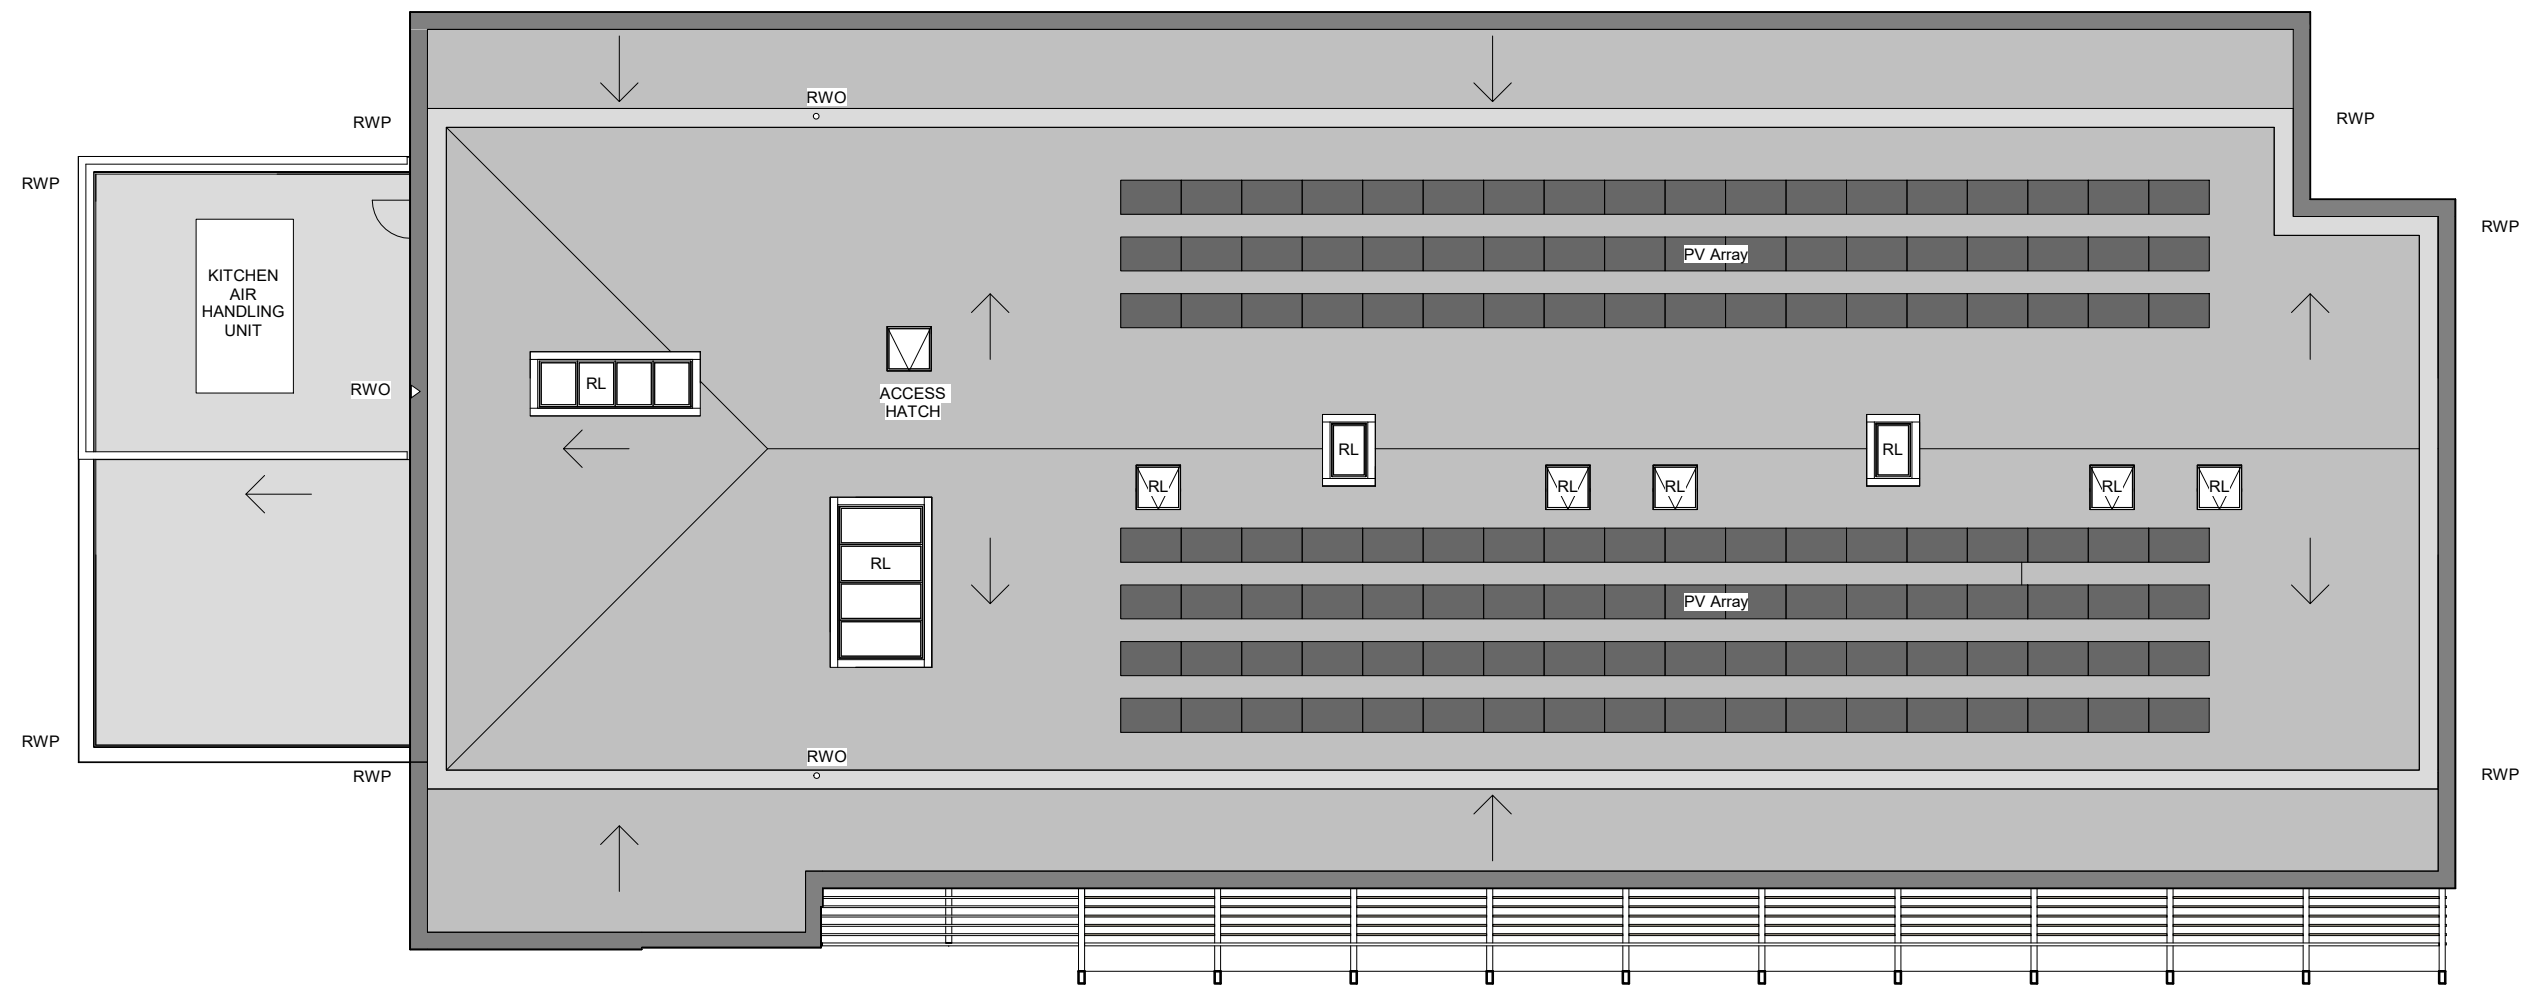

Rev	Description	Date	By	Chkd
P1	Planning Submission	July '23	FB	HCC

HCC Property Services,
Three Minsters House,
76 High Street, Winchester SO23
8UL



Wellesley Eastern Primary
Aldershot, Hampshire

Proposed Roof Plan

SCALE
As indicated @ A1

DRAWN ET
CHKD FB

DRAWING No.
project code - originator - volume - level - type - role - number revision version
P12462-HCC-PS-RL-DR-A-205 P01 .1

SUITABILITY
code description
PLANNING